


STADIUM AREA-ELECTRICAL
SCALE: 1/4" = 1'-0"


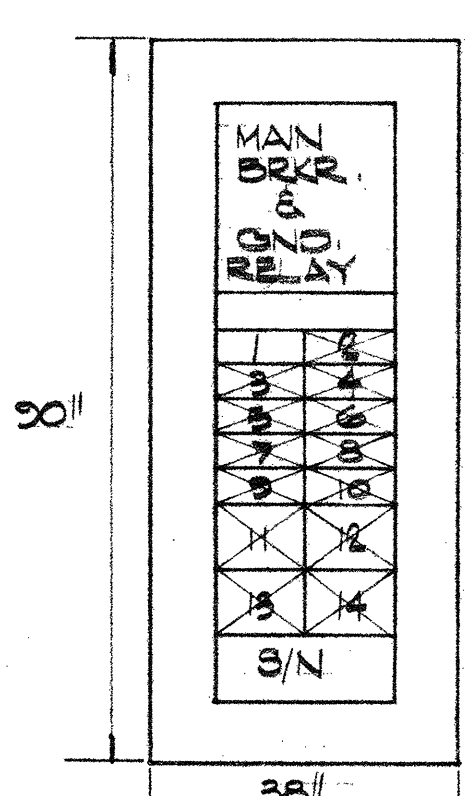


① DISTRIBUTION PANEL
NOT TO SCALE

DISTRIBUTION PANEL SCHEDULE (77/480V-3P-4W-800AMP BUS)				
NO.	NAMEPLATE	CIRCUIT BREAKER POLE FRAME TRIP		REMARKS
1	MAIN BREAKER	3 M A 800A		
2	IRRIGATION CONTROLLER	2 MRA 100A		
3	SPACE/UT FOOTBALL FLD. ITR	3		
4		3		
5		3		
6		3		
7		3		
8		3		
9	(FUT. SEWAGE ELECTOR)	3		
10		3		
11	SPACE/UT BASEBALL FLD. ITR	3 LAB		
12		3		
13	(FUT. FIELDHOUSE)	3		
14		3		

PANELBOARD SCHEDULE (77/480V-3P-4W-800AMP BUS - WEATHER PROOF)						
PANEL	MTG.	MAIN BUS	POLE TRIP	BRANCH CIRCUIT NO.	SPACES	REMARKS
X	SURFACE 100A	1	2	12	12	TYPE 'EA' BREAKERS
		2	3	12	12	
		3	3	12	12	
Y	SURFACE 100A	1	2	12	12	TYPE 'EA' BREAKERS
		2	3	12	12	
		3	3	12	12	

- CONCRETE PULL BOXES**
- ① CRISTY CONCRETE PRODUCT NO. N-30 (13/16" X 14" X 22") COMPLETE W/ CONCRETE BASE & LID.
 - ② CRISTY CONCRETE PRODUCT NO. N-14 (11" X 11" X 22") COMPLETE W/ CONCRETE BASE & LID.
 - ③ SEE DETAIL #1 - SHEET 88 IN SPEC.
 - ④ SEE DETAIL #2 - SHEET 88 IN SPEC.
 - ⑤ CRISTY CONCRETE PRODUCTS NO. N-9 (19/16" X 10 5/8" X 24") COMPLETE W/ CONCRETE BASE & LID.

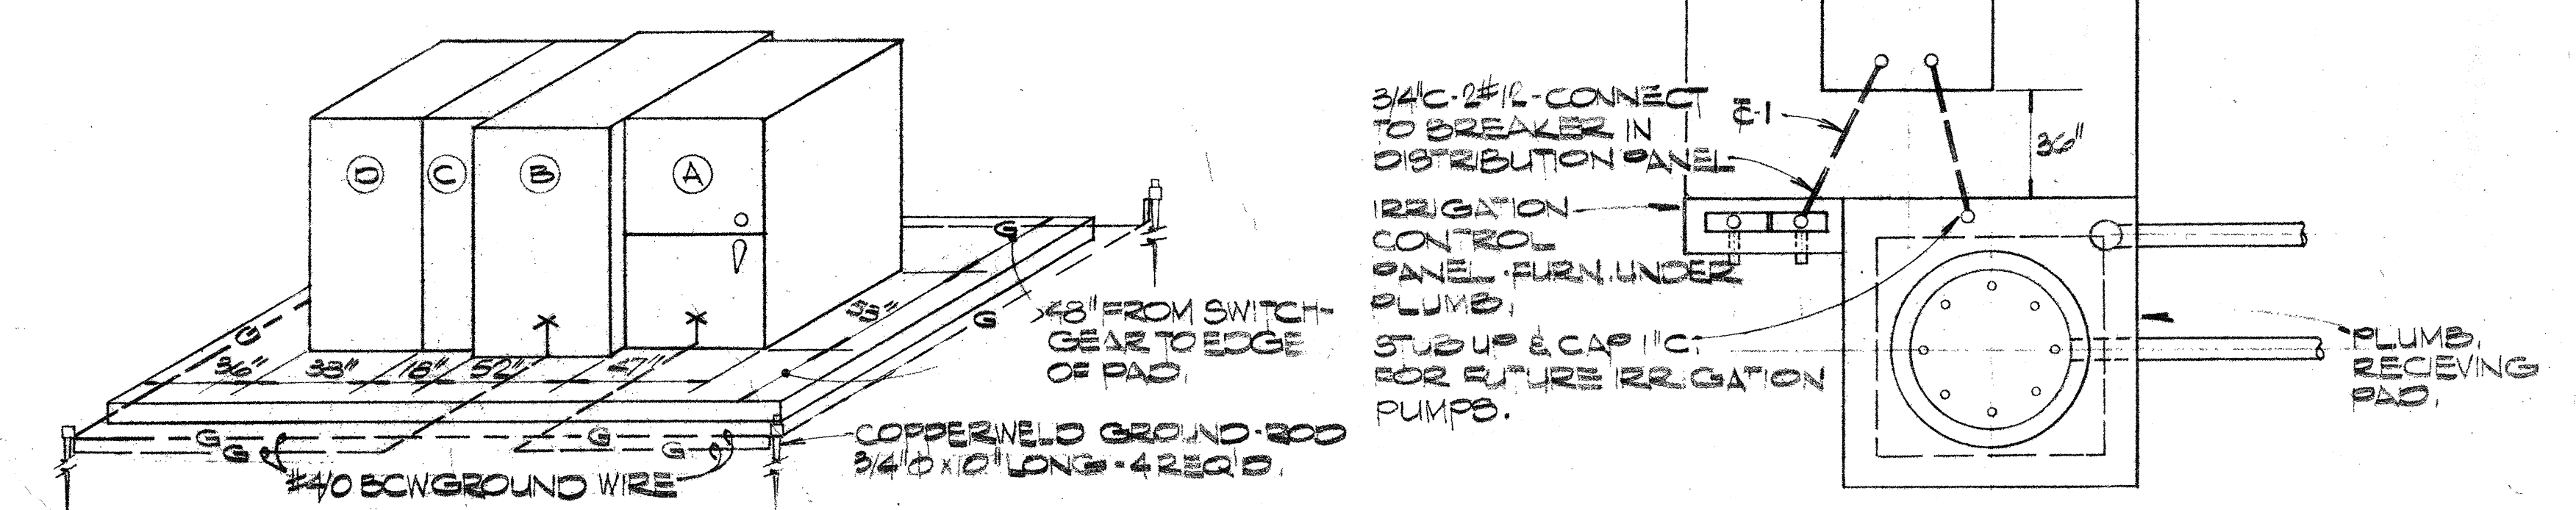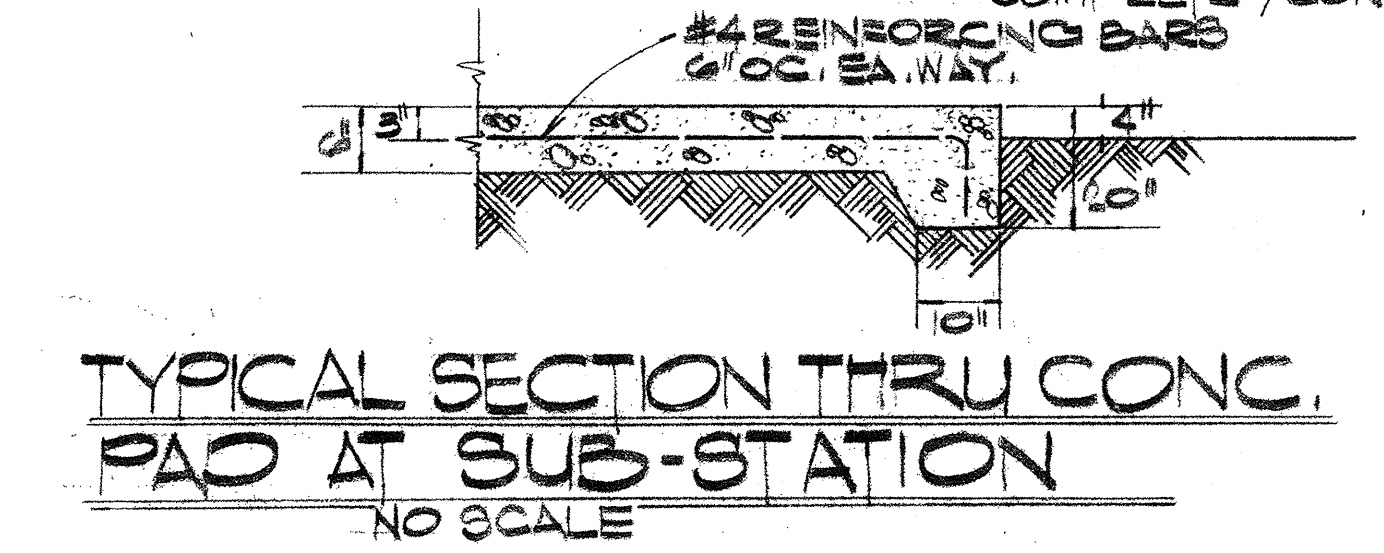

- ① LOAD BREAKER AIR SWITCH 3P 400A 12KV 30AMP CLF.
- ② TRANSFORMER (LIG. I.M.M.) 500KVA 12KV-77/480V-3P 4W.
- ③ TRANSITION SECTION
- ④ DISTRIBUTION SECTION - SEE DETAIL THIS SHEET.

UNIT SUB-STATION (WEATHER PROOF)
NOT TO SCALE

CHANGE ORDER ITEMS

REV#	DESCRIPTION	BY	DATE
Δ	ADDED PULL BOXES @ TRACK	E.N.	8/26/70